


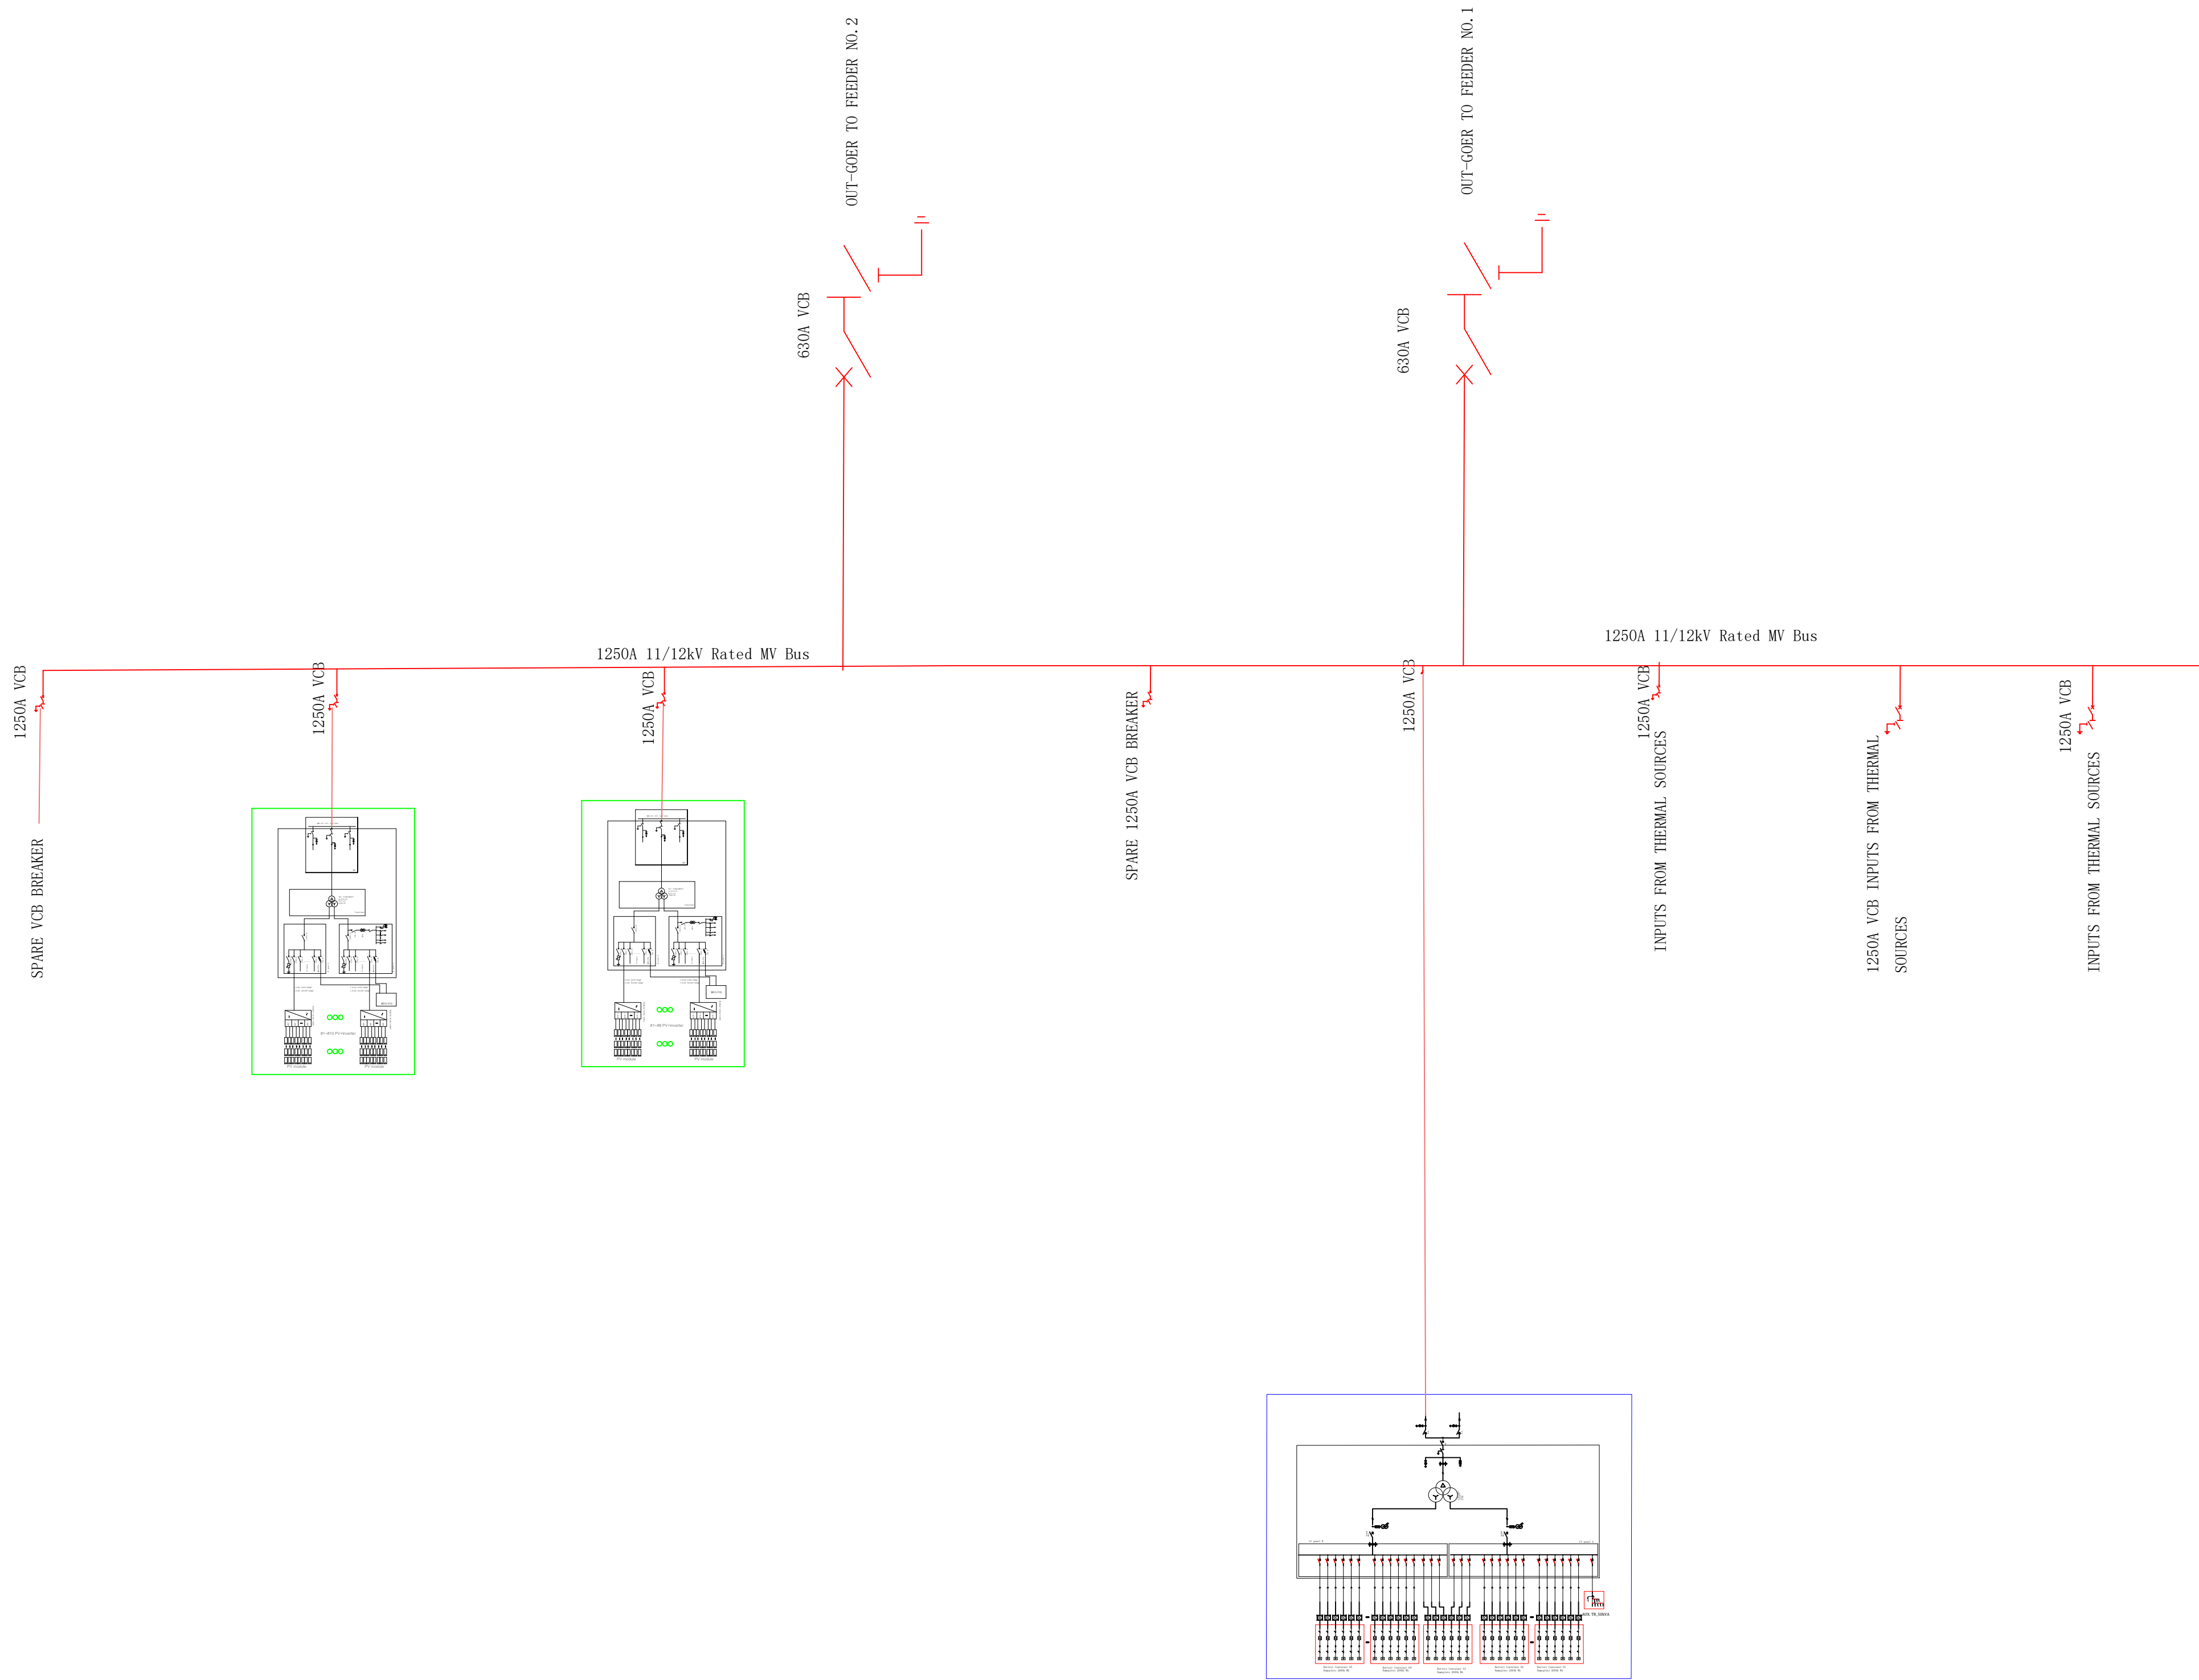

SINGLE LINE DIAGRAM FOR THE PROPOSED PV POWER PLANT FOR BEC ELECTRICITY SERVICE PROVIDE IN KISMAYO, SOMALIA

NOTES

REVISIONS, ADDITIONS & ALTERATIONS			
NO	DATE	DESCRIPTION	BY

CONSULTANTS

CLIENT

PROJECT

WESCO- PROPOSED HYBRID
SOLAR PV POWER PLANT
WITH BESS

DRAWING NAME

DRAWING NAME

PROJECT NO	A201			
	A201/BF/L1/24			
			DATE	
			DATE	
REVISION NO	0	SCALE 1:100@A1		